
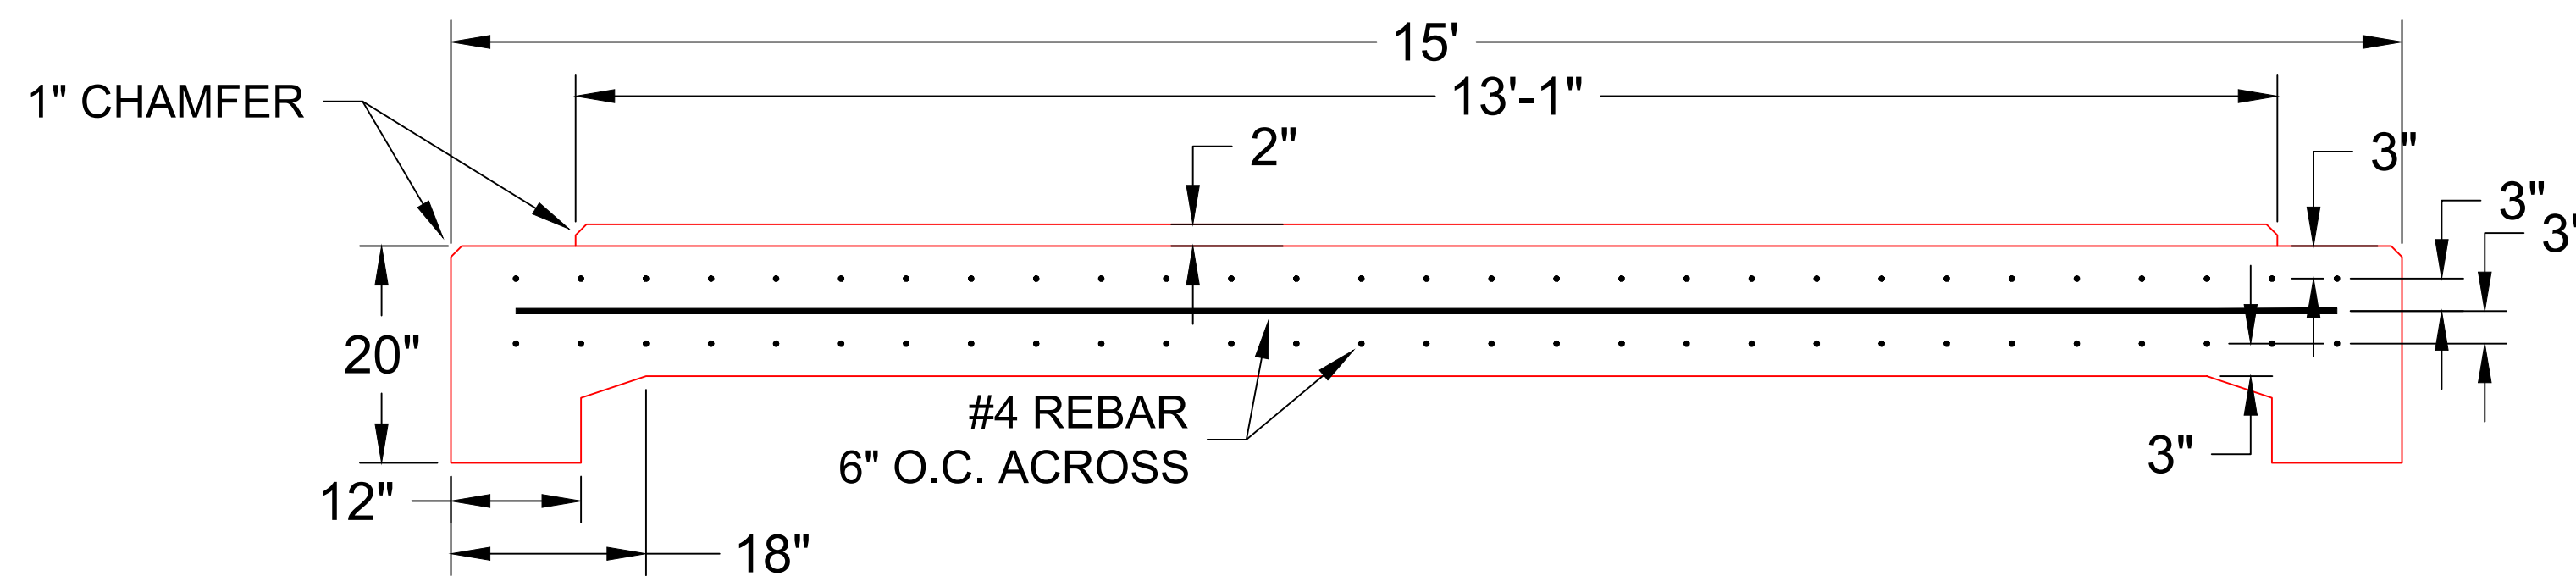
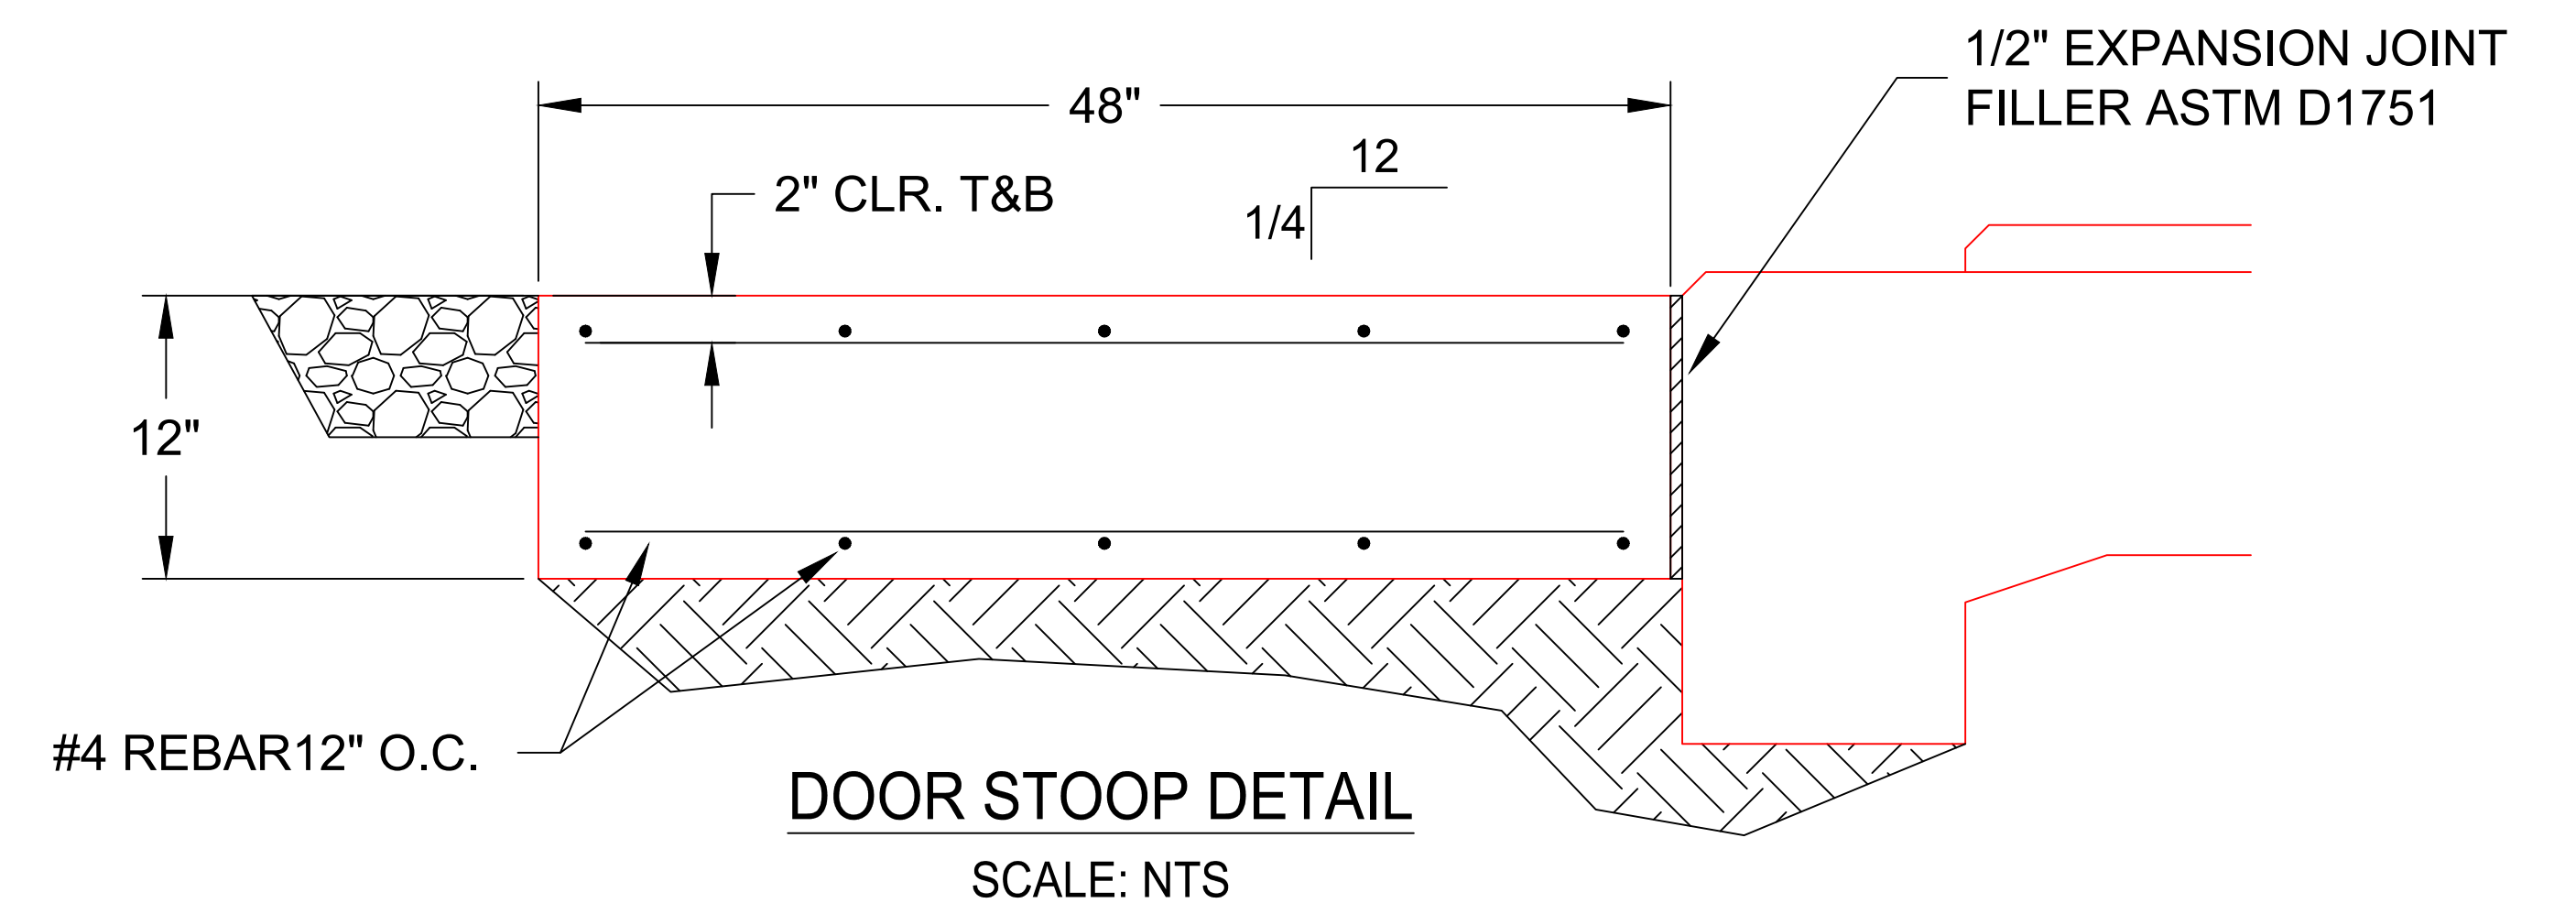



NOTES:

1. PROVIDE CHAMFERS AS NOTED.
2. $f_c = 4000$ PSI
3. $f_s = 20,000$ PSI
4. ALL WORK TO BE IN CONFORMANCE WITH A.C.I. SPECIFICATIONS, LATEST EDITION.
5. REINFORCING RODS IN STRUCTURAL FOOTINGS AND PADS SHALL BE BONDED TOGETHER AND TIED TO GROUND GRID.
6. ALL CONDUITS TO BE SET WITH A HALF COUPLING ABOVE THE CONCRETE SURFACE (SEE DWG E6-1 CONDUIT PLAN).
7. ALL STEEL TO BE UNIFORMLY AND EVENLY SUSPENDED FROM THE TOP OF FORMS. WHEN CONCRETE CAN FIRMLY SUPPORT STEEL, SUSPENSION WIRES TO BE REMOVED TO 2" BELOW CONCRETE SURFACE AND FINAL FINISH APPLIED. ALL STEEL REBAR TO BE GRADE 40.
8. ALL ABOVE GRADE SURFACES TO BE TROWEL FINISHED.

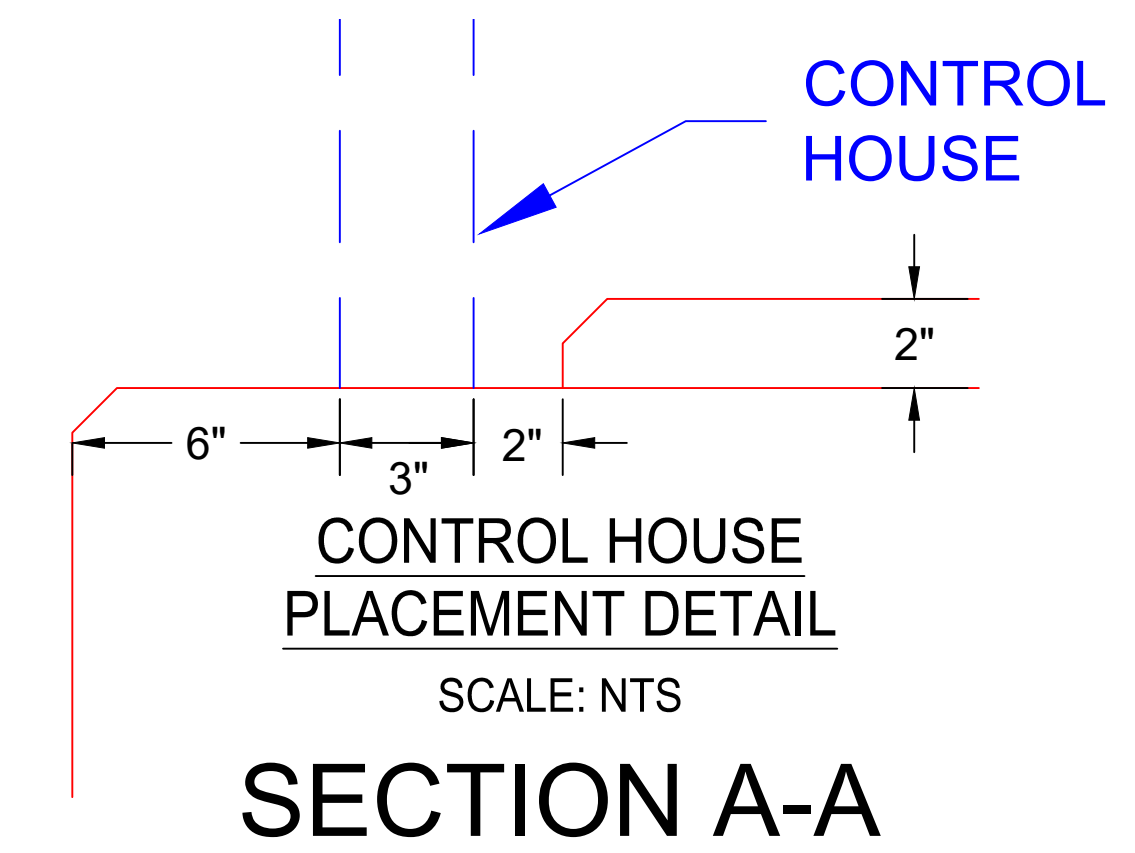


										DSGN	BENP	7/13/22		CLALLAM COUNTY PUD	JOB NUMBER	REV	
										DRN	BENP	7/13/22			LIBERTY STATION	21-2316	0
										CKD						CONTROL HOUSE FOUNDATION DETAILS	DRAWING NUMBER
0	ISSUED FOR CONSTRUCTION	12/6/23	BENP	BENP						SCALE: 1" = 20'		FOR 22334 DWG ONLY					
REV	REVISIONS	DATE	DRN	DSGN	CKD	APPD	REFERENCE DRAWINGS										

CONDUIT ID	SIZE
1A	1"
1B	2"
2A	1"
2B	2"
3A	2"
3B	1-1/2"
4A	2"
4B	1-1/2"
5B	2"
5C	1-1/4"
5D	1"
5E	4"
5G	1"

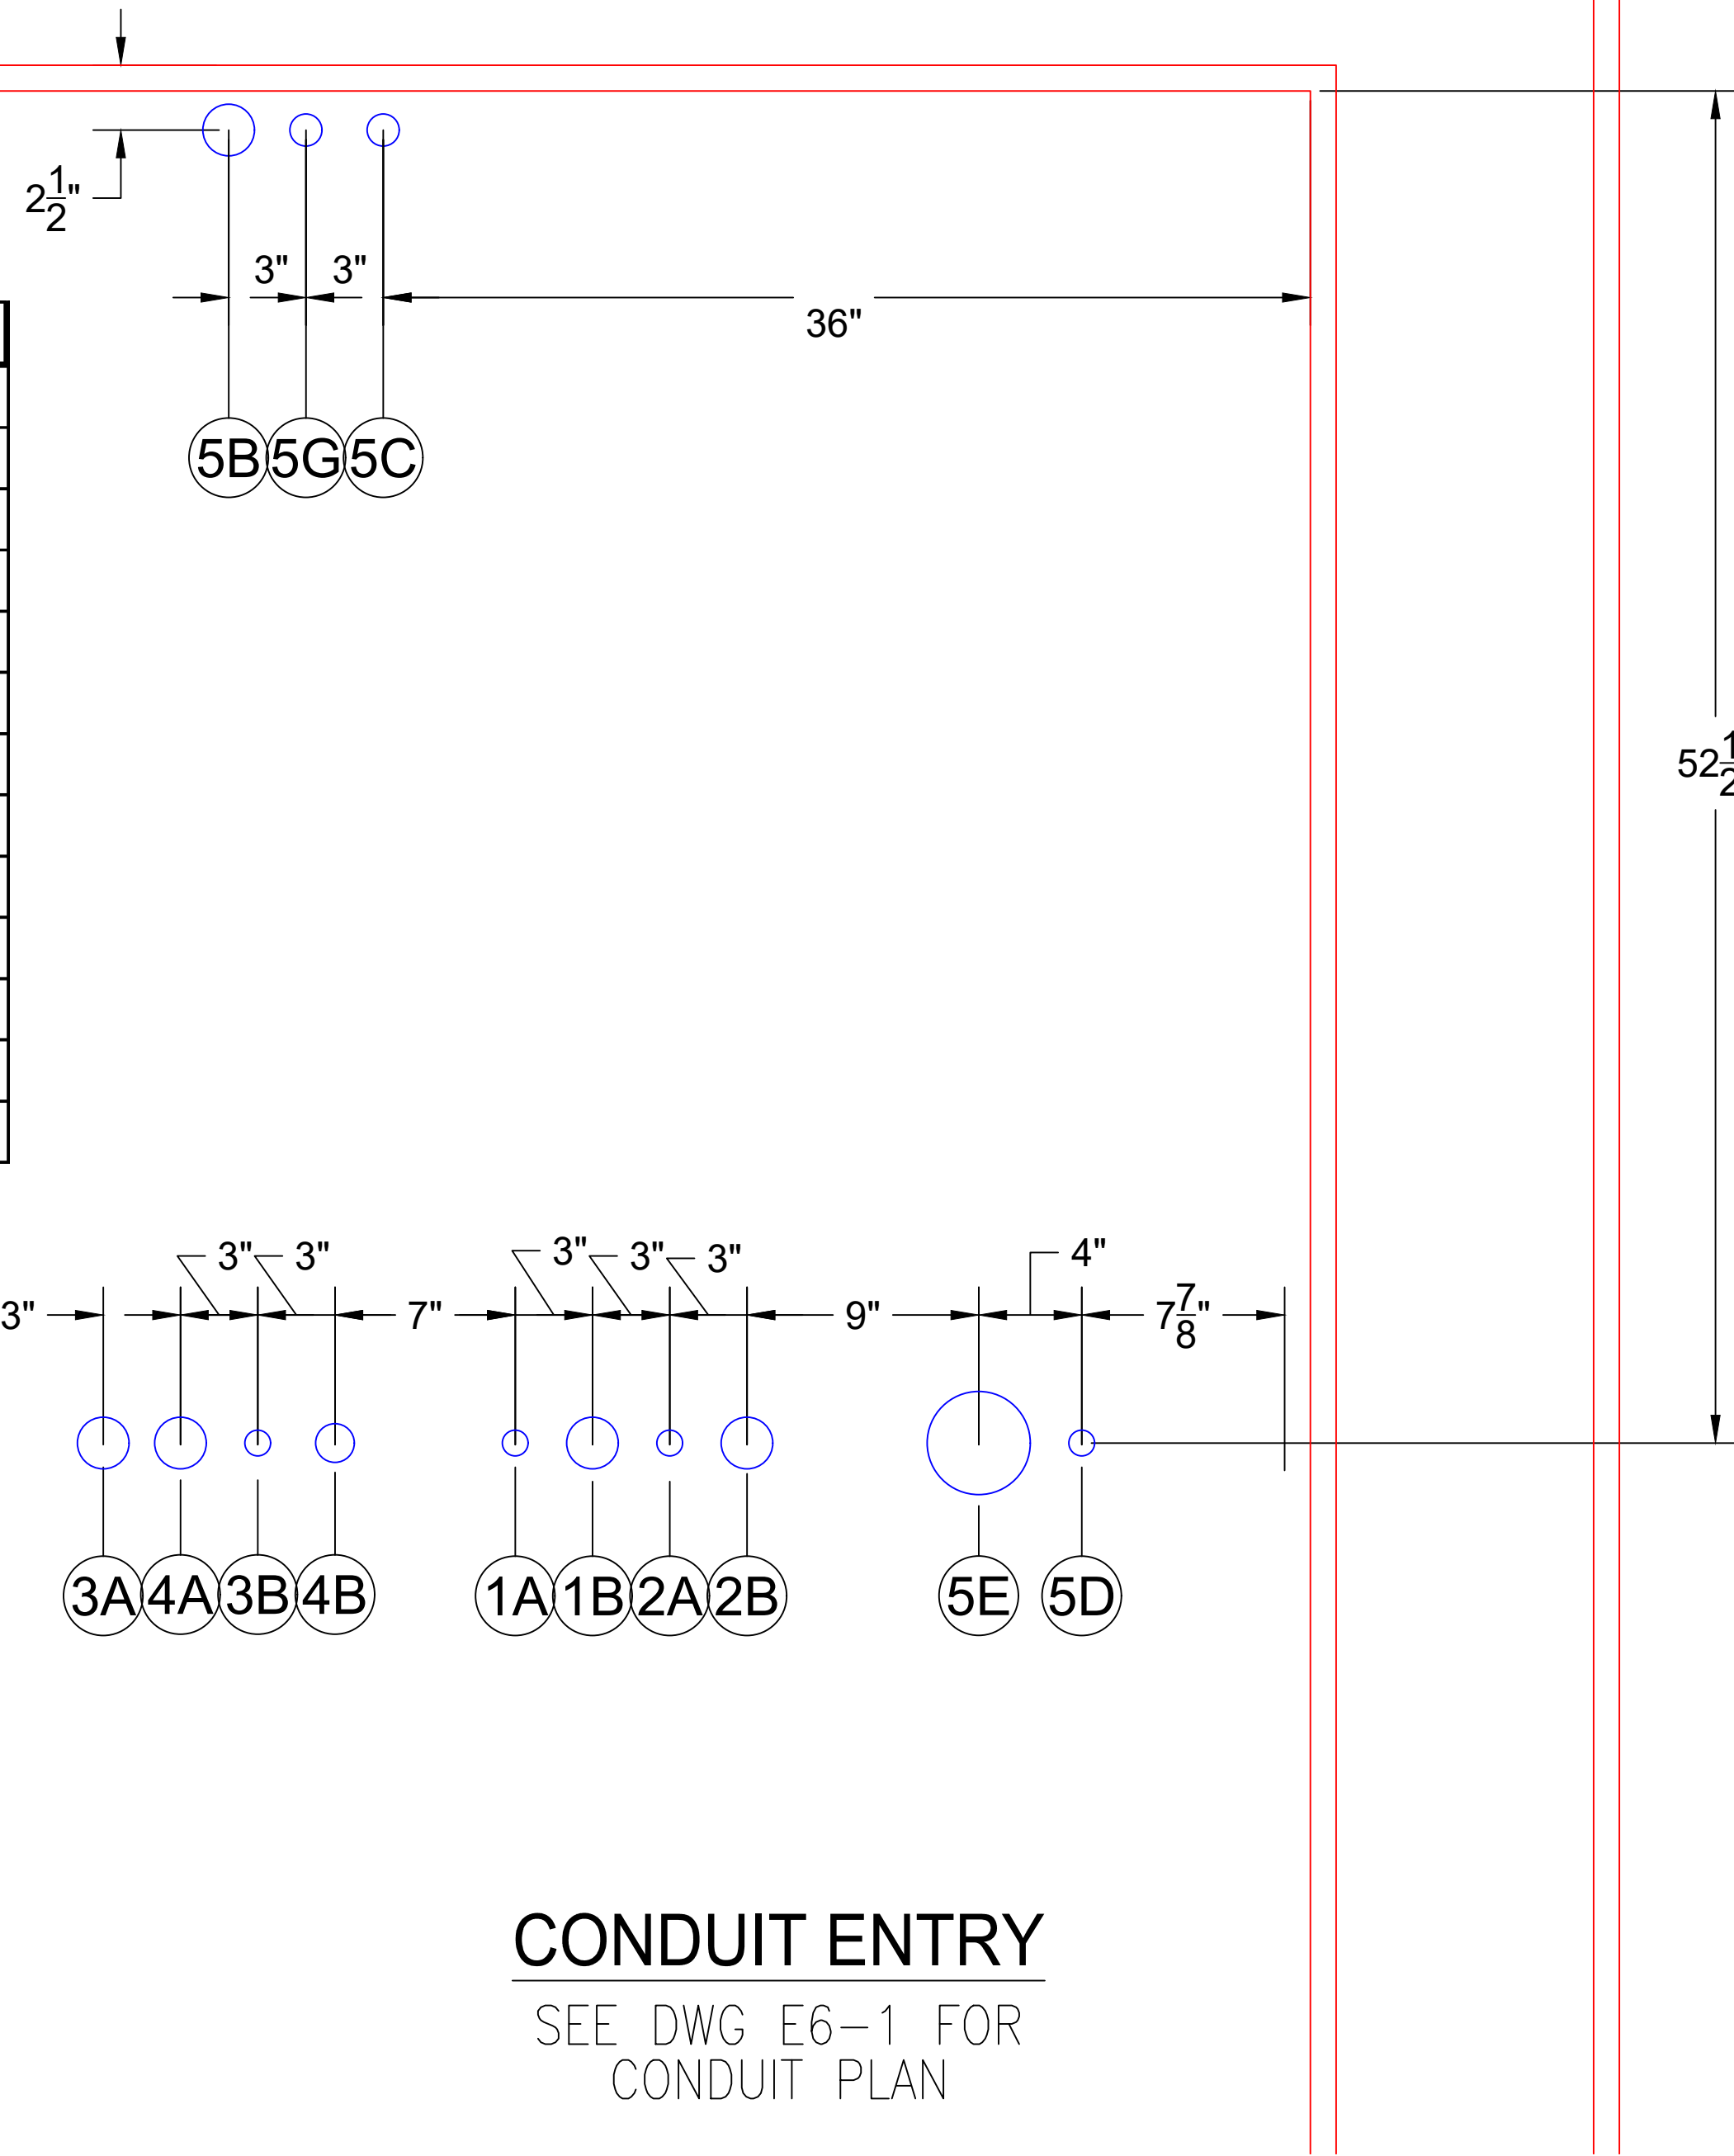



CONDUIT ENTRY
SEE DWG E6-1 FOR
CONDUIT PLAN

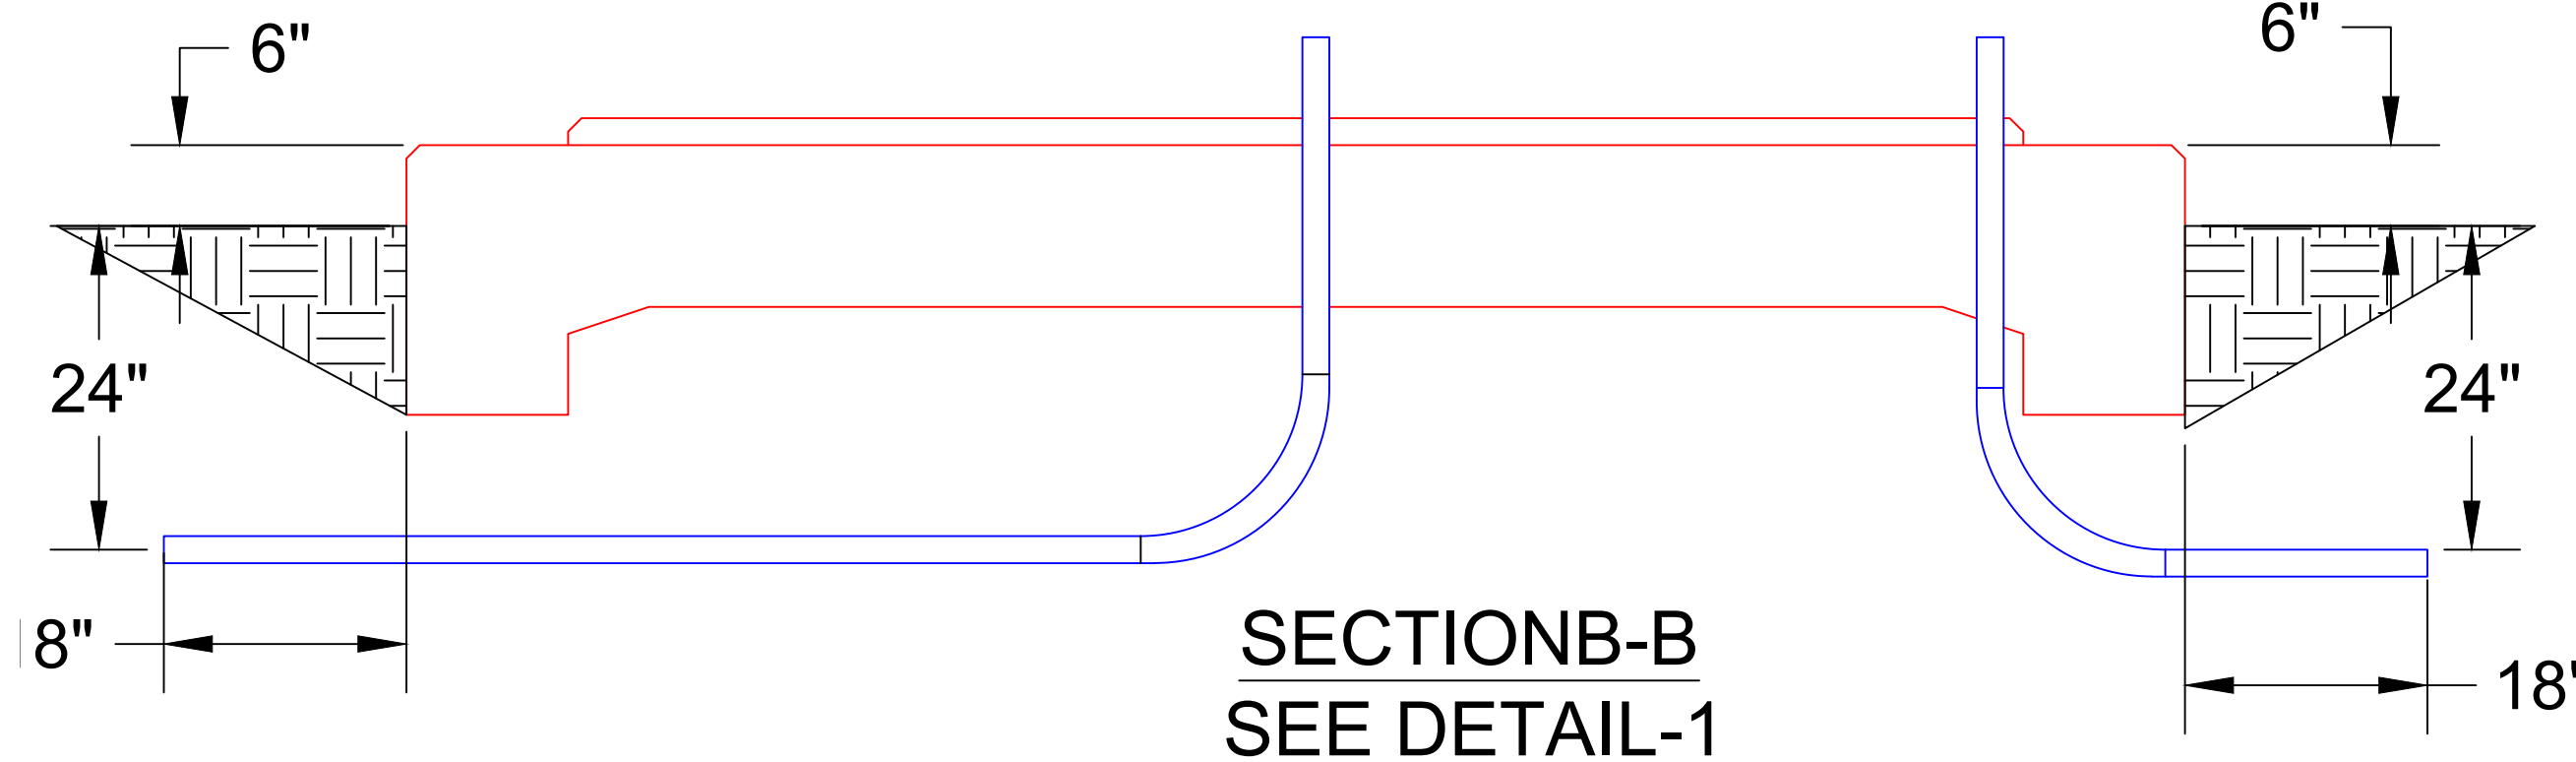


SECTION B-B
SEE DETAIL-1

GENERAL NOTES:

- 1) ALL ABOVE GROUND CONDUIT TO BE RGS
- 2) ALL BELOW GROUND CONDUIT TO BE SCH 80 PVC
- 3) REFER TO THE CONSTRUCTION SPECIFICATIONS FOR PVC SCHEDULE AND INSTALLATION AND MATERIAL REQUIREMENTS
- 4) CONDUITS SHALL BE BURIED A MINIMUM OF 24" BELOW GRADE.
- 5) ALL RGS CONDUIT TERMINATIONS AT EQUIPMENT CABINETS, JUNCTION BOXES, PULL BOXES, VAULTS, ETC., SHALL BE PROVIDED WITH GROUNDING BUSHINGS. GROUNDING BUSHING SHALL BE CONNECTED TO GROUND BUS BARS OR GROUND GRID.

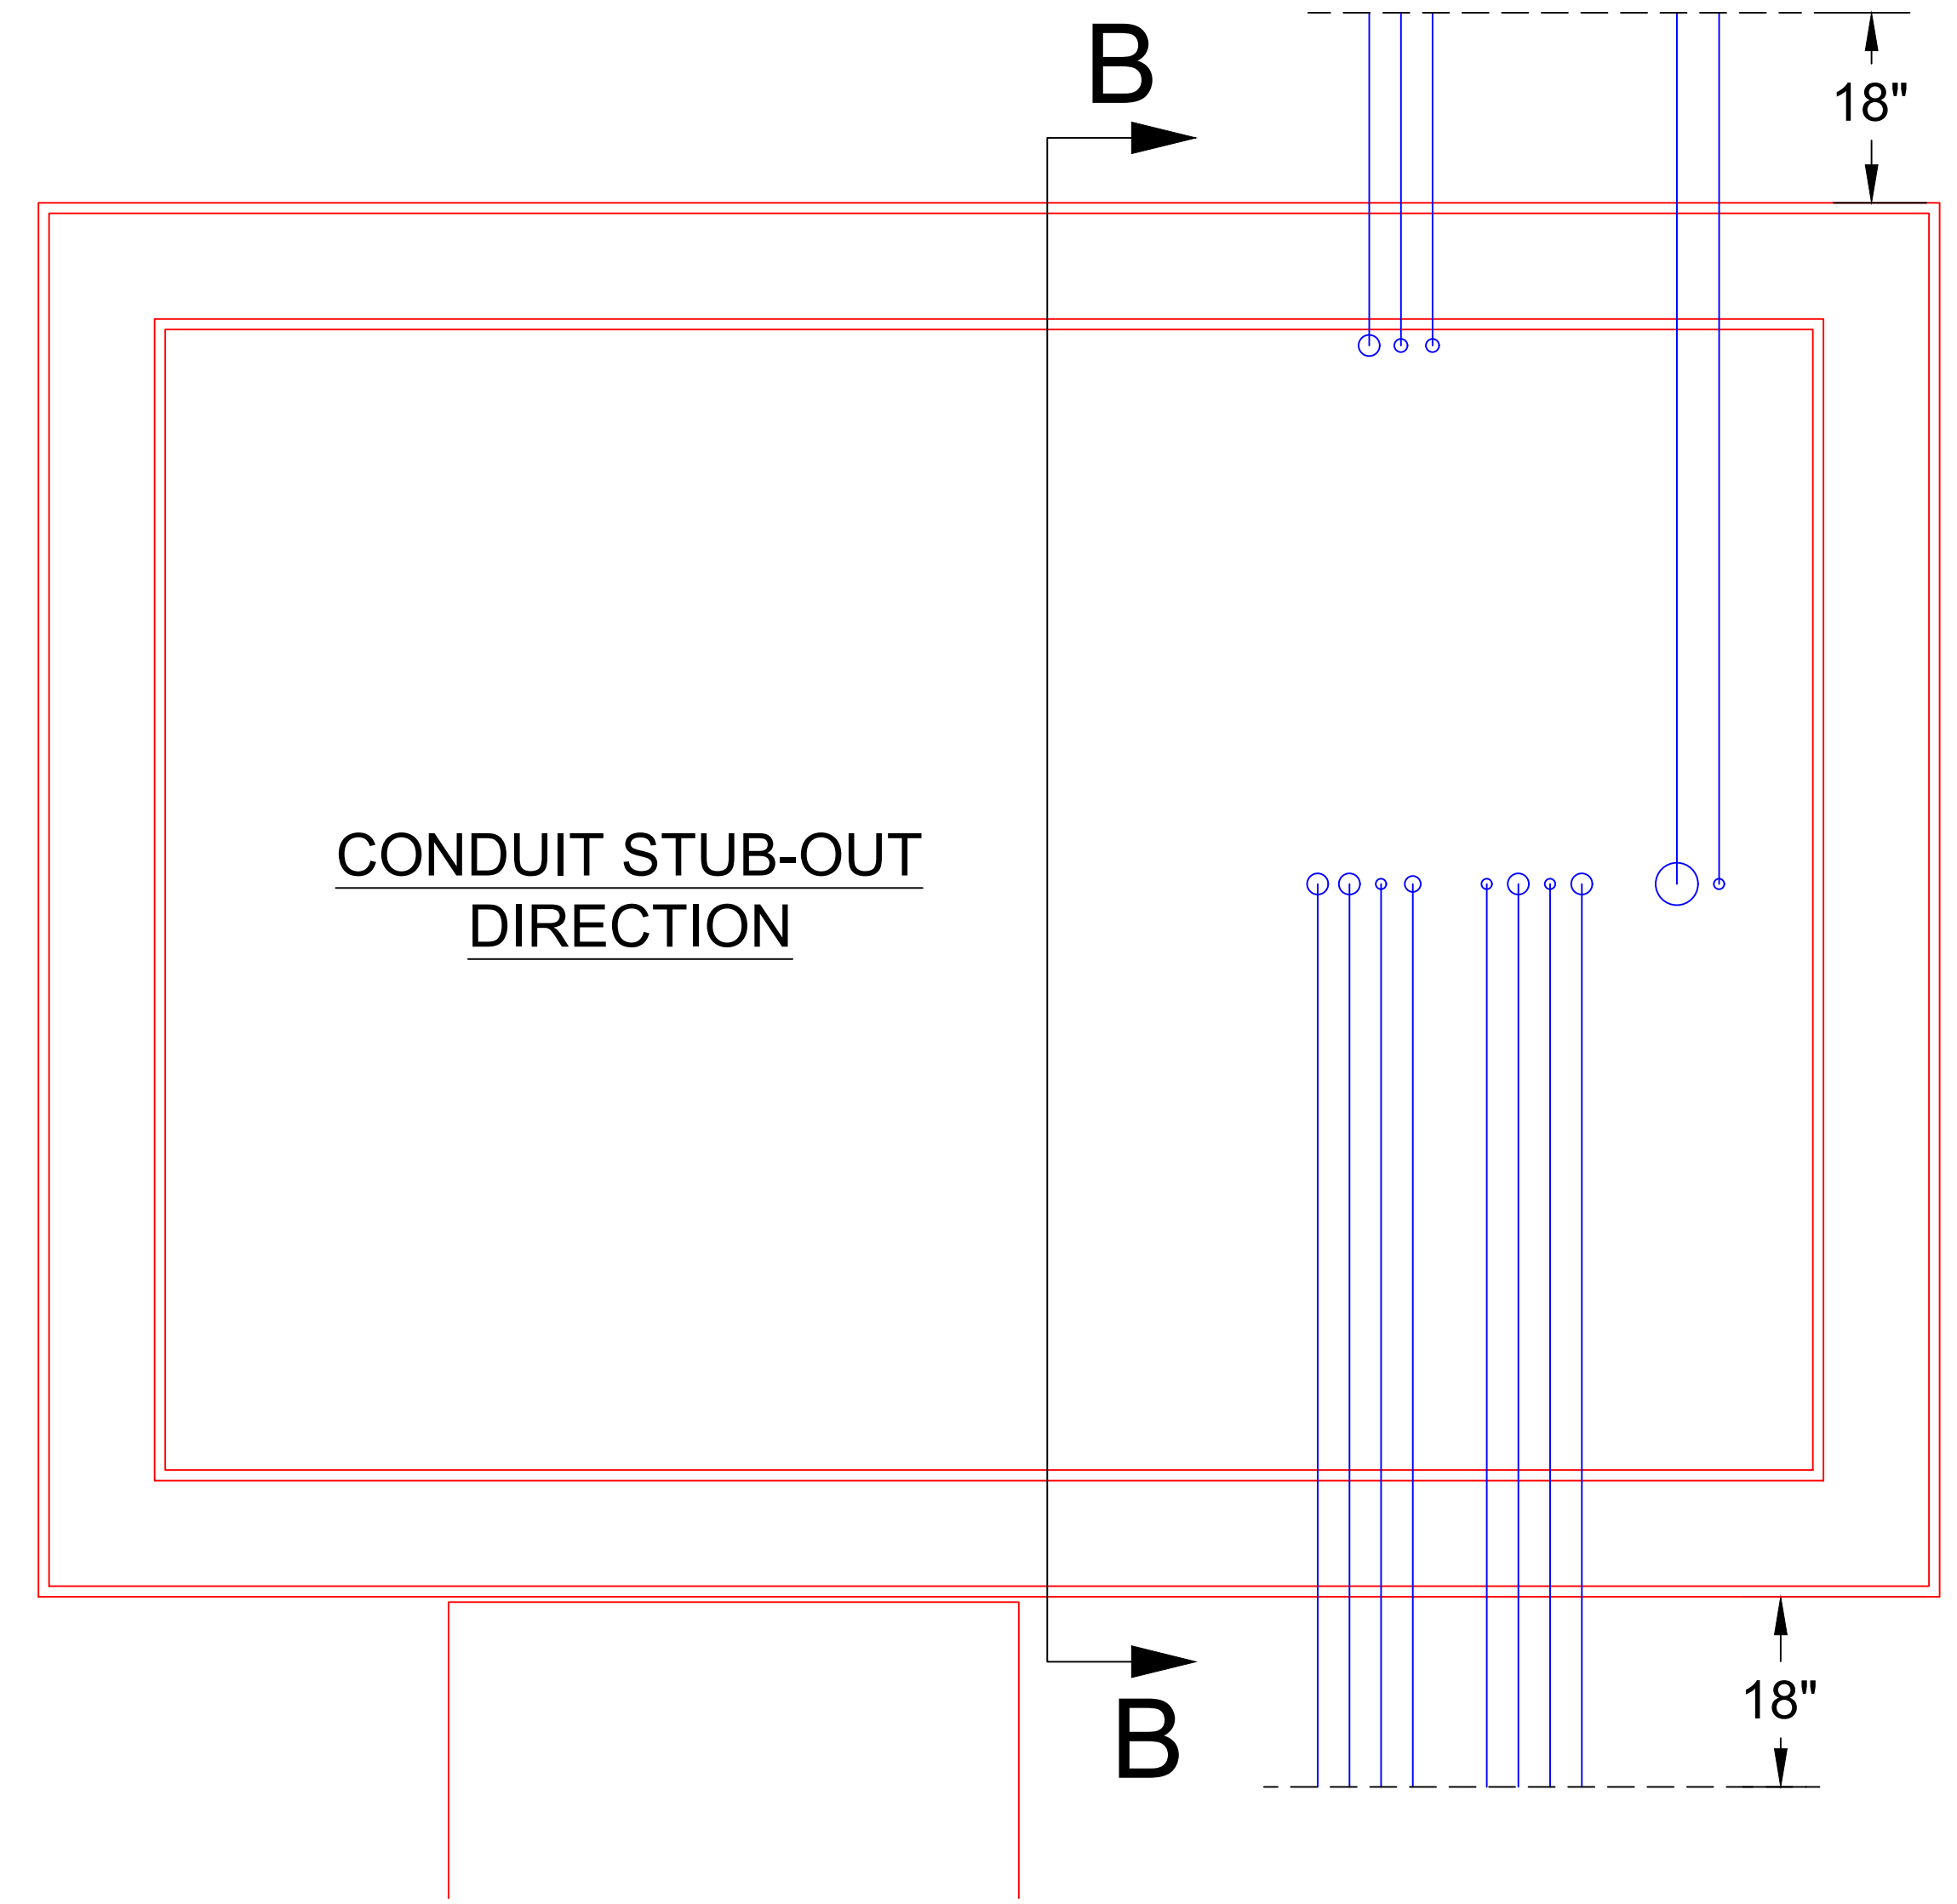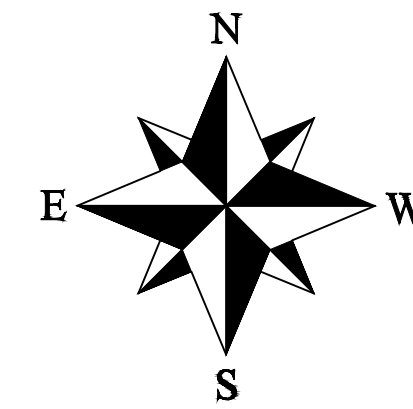

**CONDUIT STUB-OUT
DIRECTION**

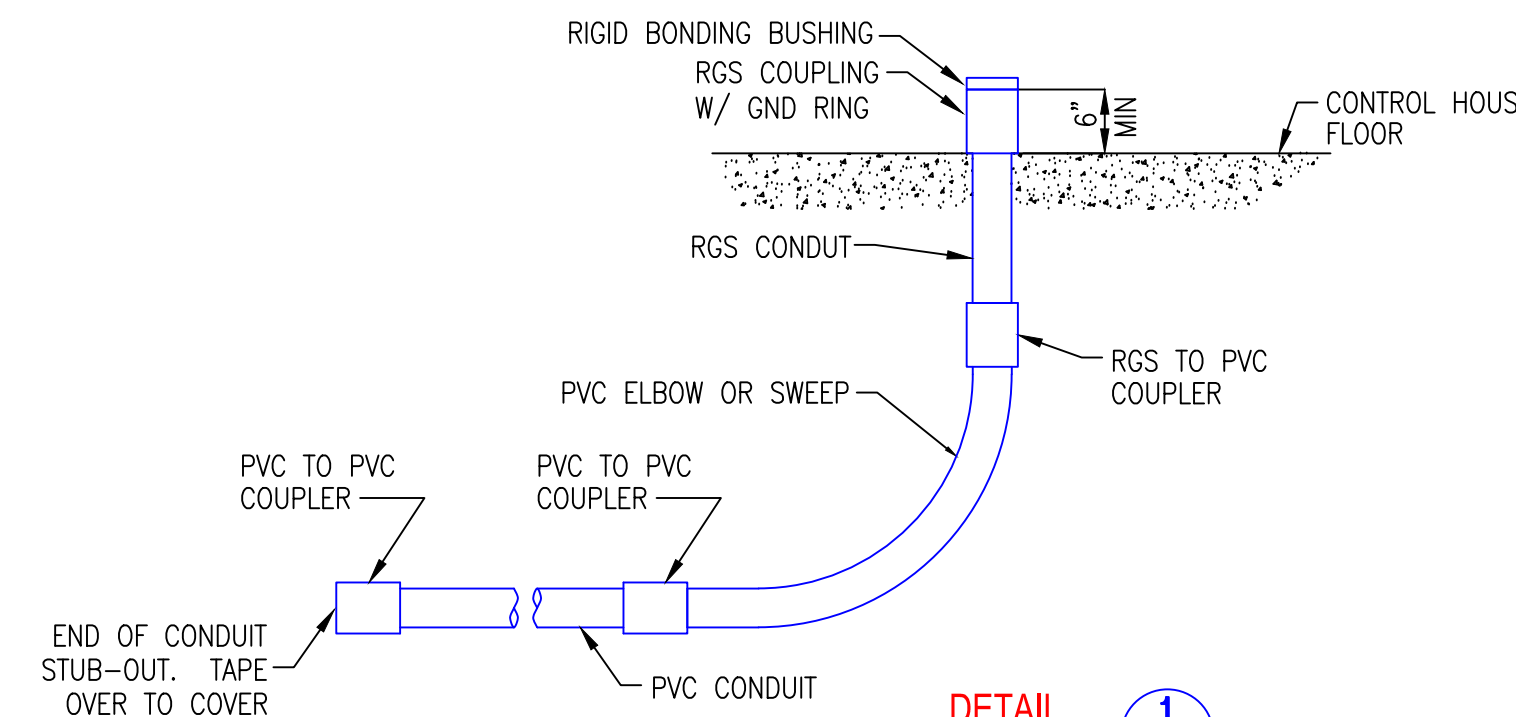

DETAIL 1
TYPICAL STUB-UP WITH ABOVE GRADE CONTROL CONDUIT
IN CONTROL HOUSE

REV	ISSUED FOR CONSTRUCTION	DATE	DRN	DSGN	CKD	APPD	REFERENCE DRAWINGS
0	ISSUED FOR CONSTRUCTION	12/6/23	BENP	BENP			E7-1 CONTROL HOUSE PLAN & ELEVATIONS E6-1 WIRE & CONDUIT SCHEDULE E5-1 STATION GROUNDING PLAN

DSGN BENP 7/13/22
 DRN BENP 7/13/22
 CKD
 SCALE: N.T.S.
 FOR 22x34 DWG ONLY



CLALLAM COUNTY PUD
 LIBERTY STATION
 CONTROL HOUSE
 FOUNDATION DETAILS

JOB NUMBER	REV
21-2316	0
DRAWING NUMBER	E4-6-2