

**REQUEST FOR BID
BID NUMBER 230804**

ADDENDUM NO. 3

Date: February 8, 2024

Re: LIBERTY STATION CONSTRUCTION

To: ALL PROSPECTIVE BIDDERS



This Addendum No. 3 forms a part of the Contract Documents and modifies the original bidding documents dated January 11, 2024. This Addendum is issued to clarify, revise, add to, or delete from the original bidding documents. Bidders shall determine the work affected by the Addendum items.

This Addendum consists of:

CORRECTION

This is to correct EXHIBIT CB - Drawing E4-0 Foundation Plan, the attached drawing corrects elevations of the top of all concrete structures.

This addendum consists of two (2) page. **THIS ADDENDUM SHEET MUST BE ACKNOWLEDGED ON THE BID PROPOSAL.**

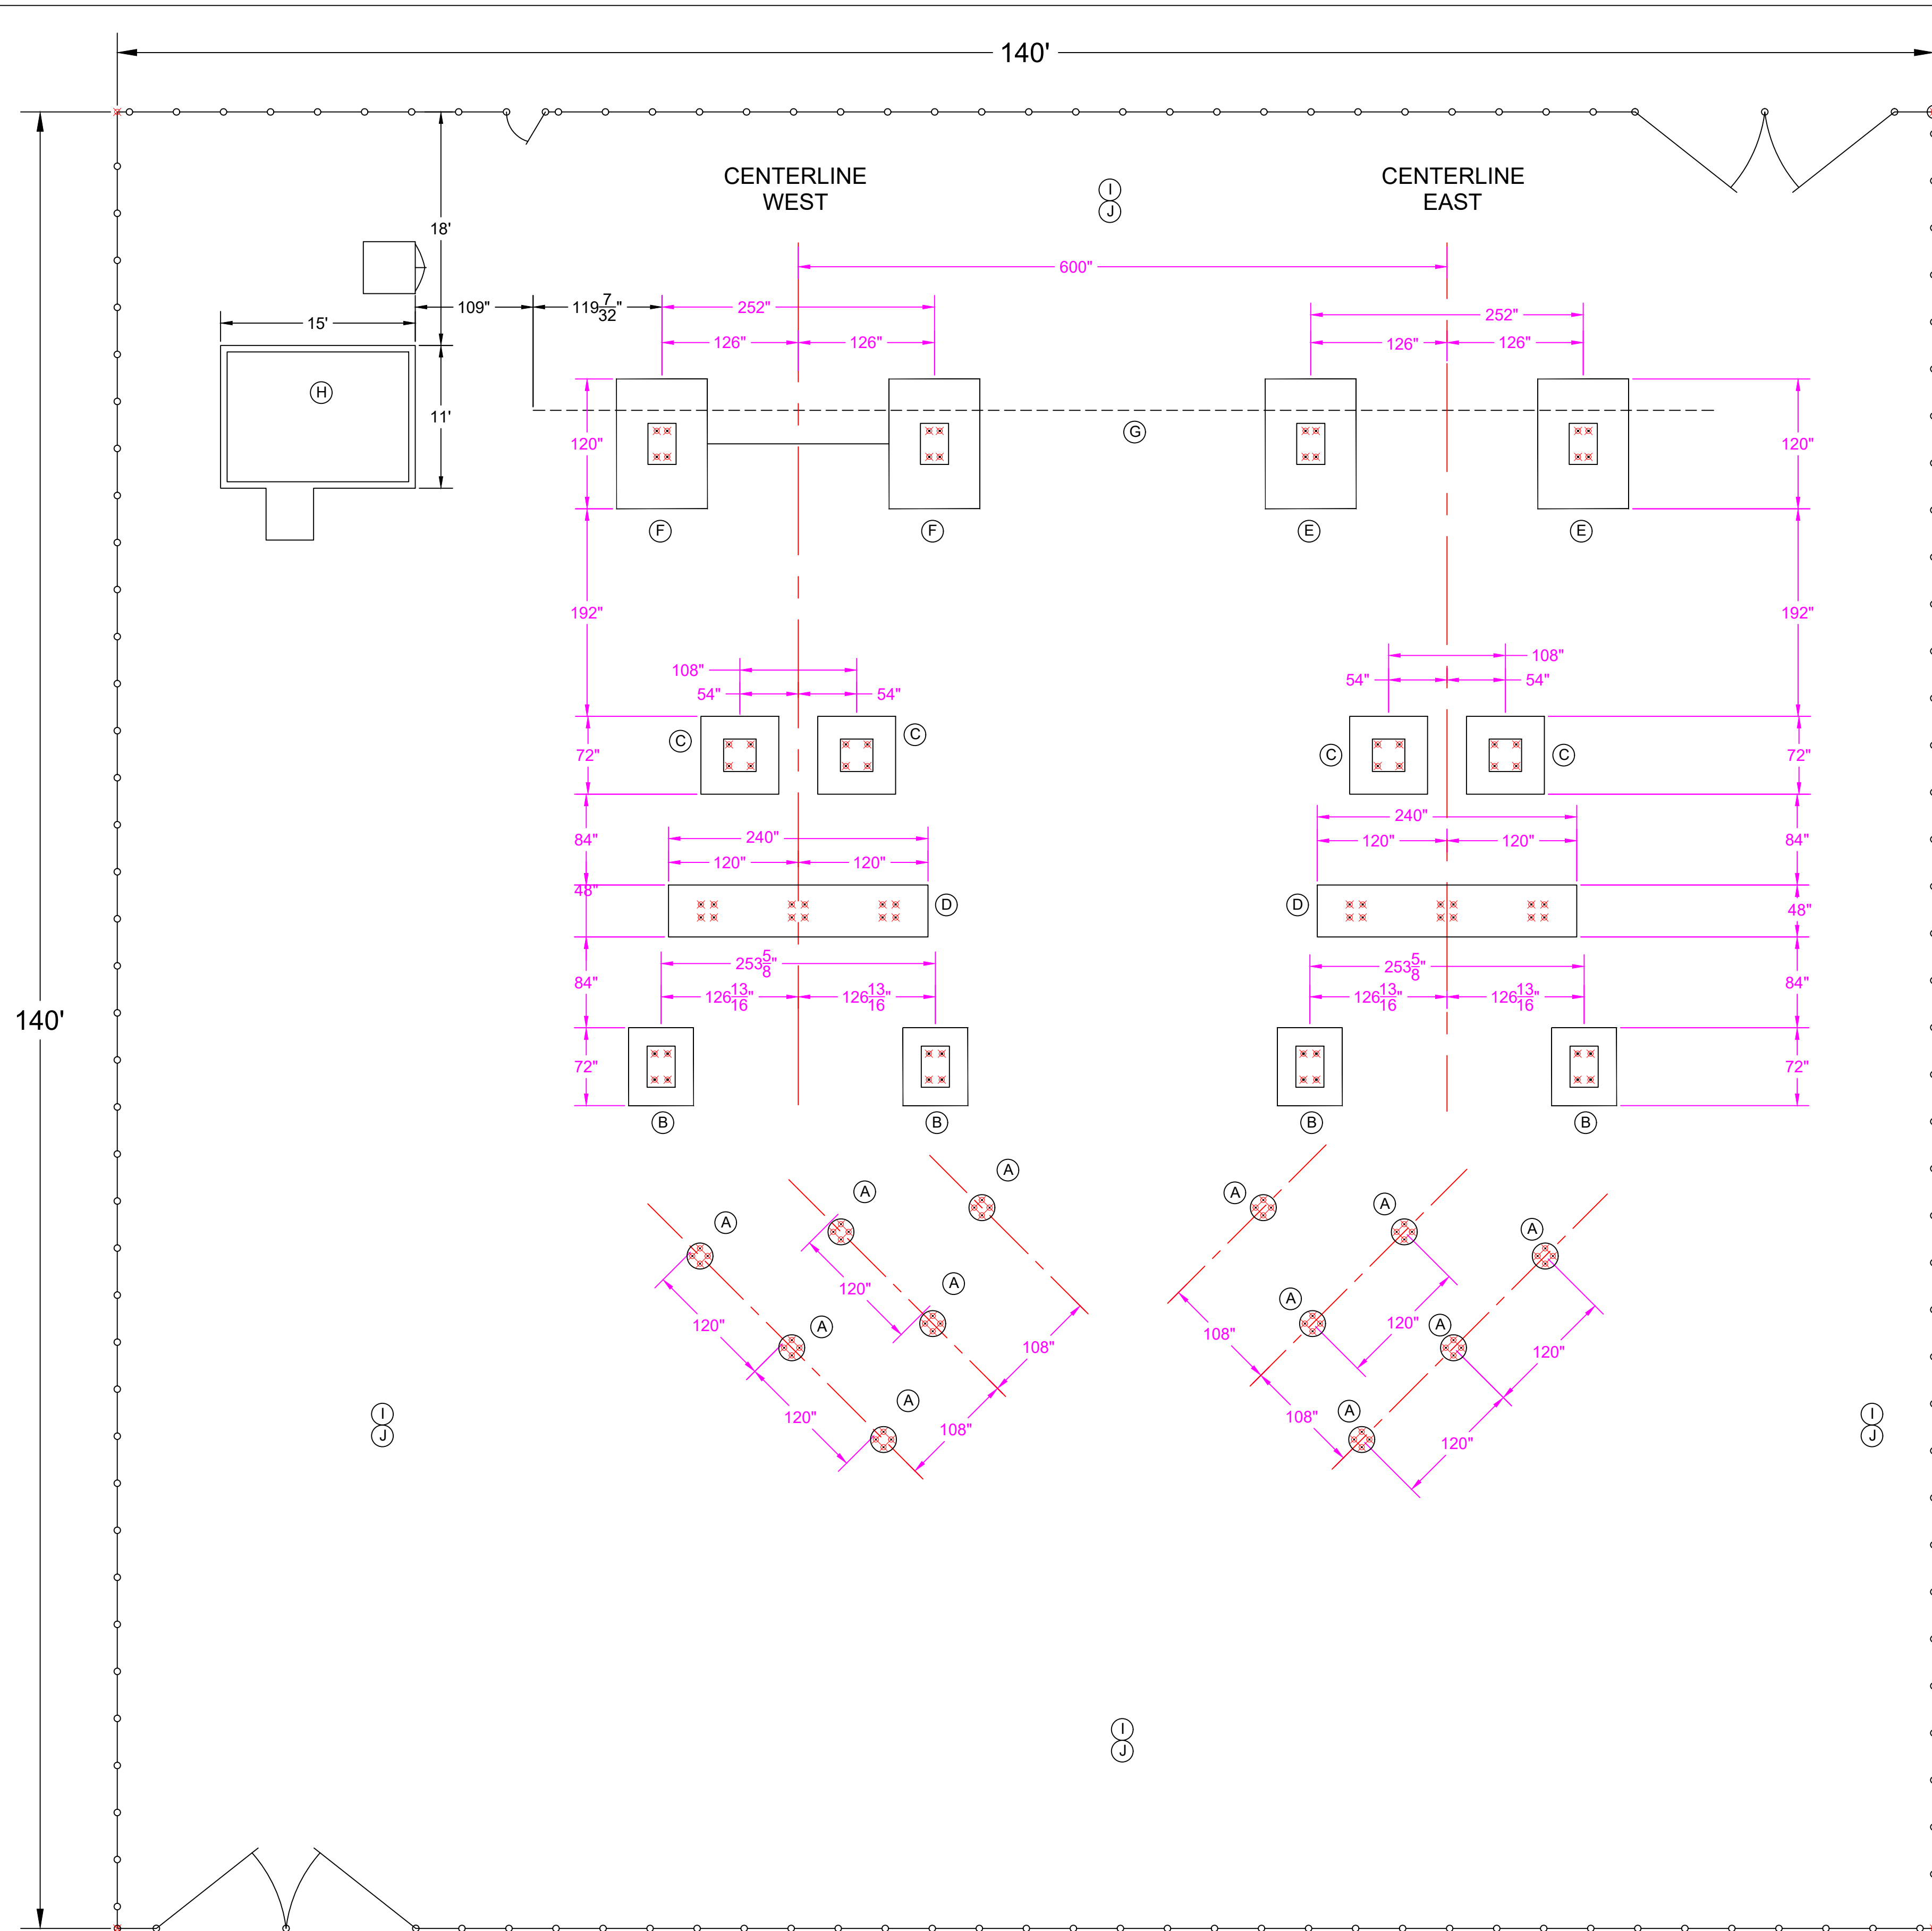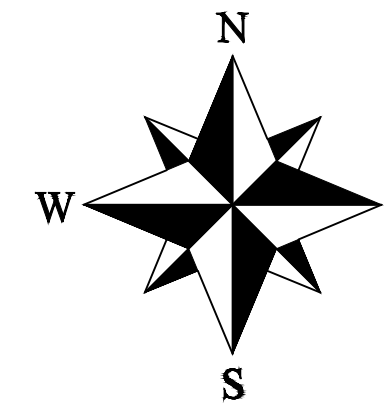


DRAWING SCHEDULE					ANCH.	MTG.
ITEM	DESCRIPTION	CONCRETE DWG	STEEL DWG	DWG	BOLT Ø	HOLE Ø
A	115KV INSULATOR	E4-4	S1-5	N/A	3/4"	13/16"
B	HIGH SIDE HORIZONTAL V-SWITCH E&W	E4-2	S1-3	N/A	1-1/4"	1-5/16"
C	CIRCUIT SWITCHER	E4-5	E2-2/E2-3	N/A	1"	1-1/4"
D	CMU	E4-3	S1-4	N/A	1"	1-1/16"
E	A-FRAME EAST (CS-1480)	E4-1	S1-1/S1-7	N/A	1-1/4"	1-5/16"
F	A-FRAME (WEST (CS-1490)	E4-1	S1-2	N/A	1-1/4"	1-5/16"
G	BPA TIE BEAM	N/A	S1-6	N/A	N/A	N/A
H	CONTROL HOUSE	E4-6	N/A	N/A	N/A	N/A
I	GRADING & ROCK DETAIL	N/A	N/A	C3-1	N/A	N/A
J	GROUNDING PLAN	N/A	N/A	E5-3	N/A	N/A

NOTES:

1. CONTRACTOR TO PROVIDE ALL SURVEYING REQUIRED.
2. PUD WILL PROVIDE CAD POINTS OF THE CENTER OF EACH ANCHOR BOLT TO THE SURVEYOR
3. DIMENSIONS IN RED ARE CRITICAL AND MUST BE MET.
4. DIMENSIONS IN MAGENTA ARE FOR GENERAL LAYOUT REFERENCE.
5. DIMENSIONS IN BLACK ARE REFERENCE
6. PUD CREWS WILL INSTALL FENCE
7. TOP OF ALL CONCRETE STRUCTURES IS ELEV 260.

REV	REVISIONS	DATE	DRN	DSGN	CKD	APPD	REFERENCE DRAWINGS
1	REVISED TOP OF CONCRETE ELEVATIONS	2/5/24	BENP				
0	ISSUED FOR CONSTRUCTION	12/6/23	BENP				


DSGN	BENP	9/2022
DRN	BENP	9/2022
CKD		
SCALE:	N.T.S.	

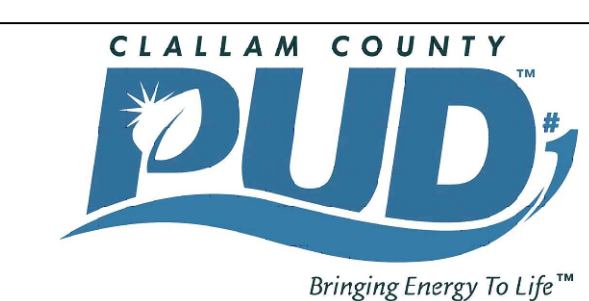

CLALLAM COUNTY PUD	JOB NUMBER	REV
LIBERTY STATION	21-2316	⚠
FOUNDATION PLAN	DRAWING NUMBER	E4-0-1



EL. 251

EL. 252

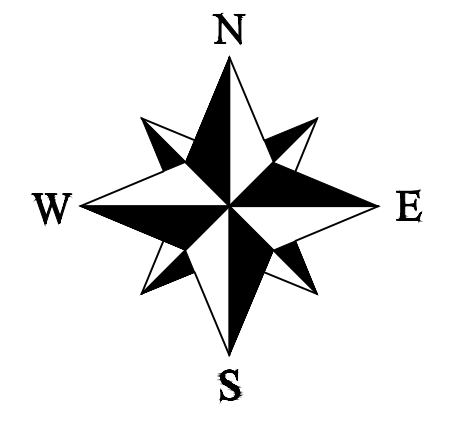

EL. 256


EL. 256

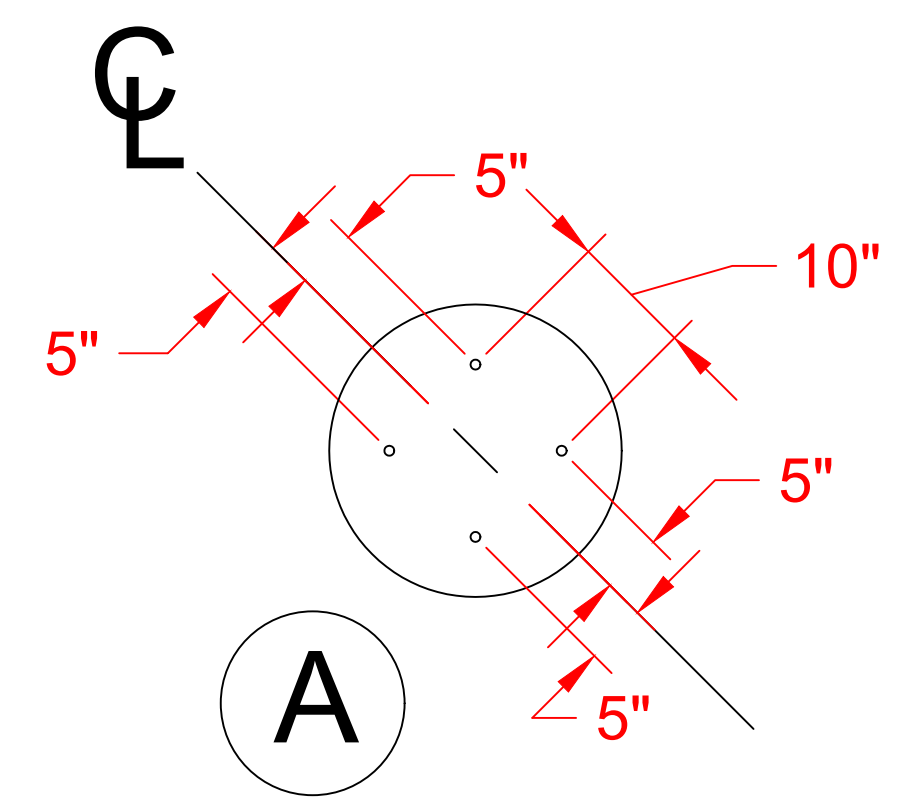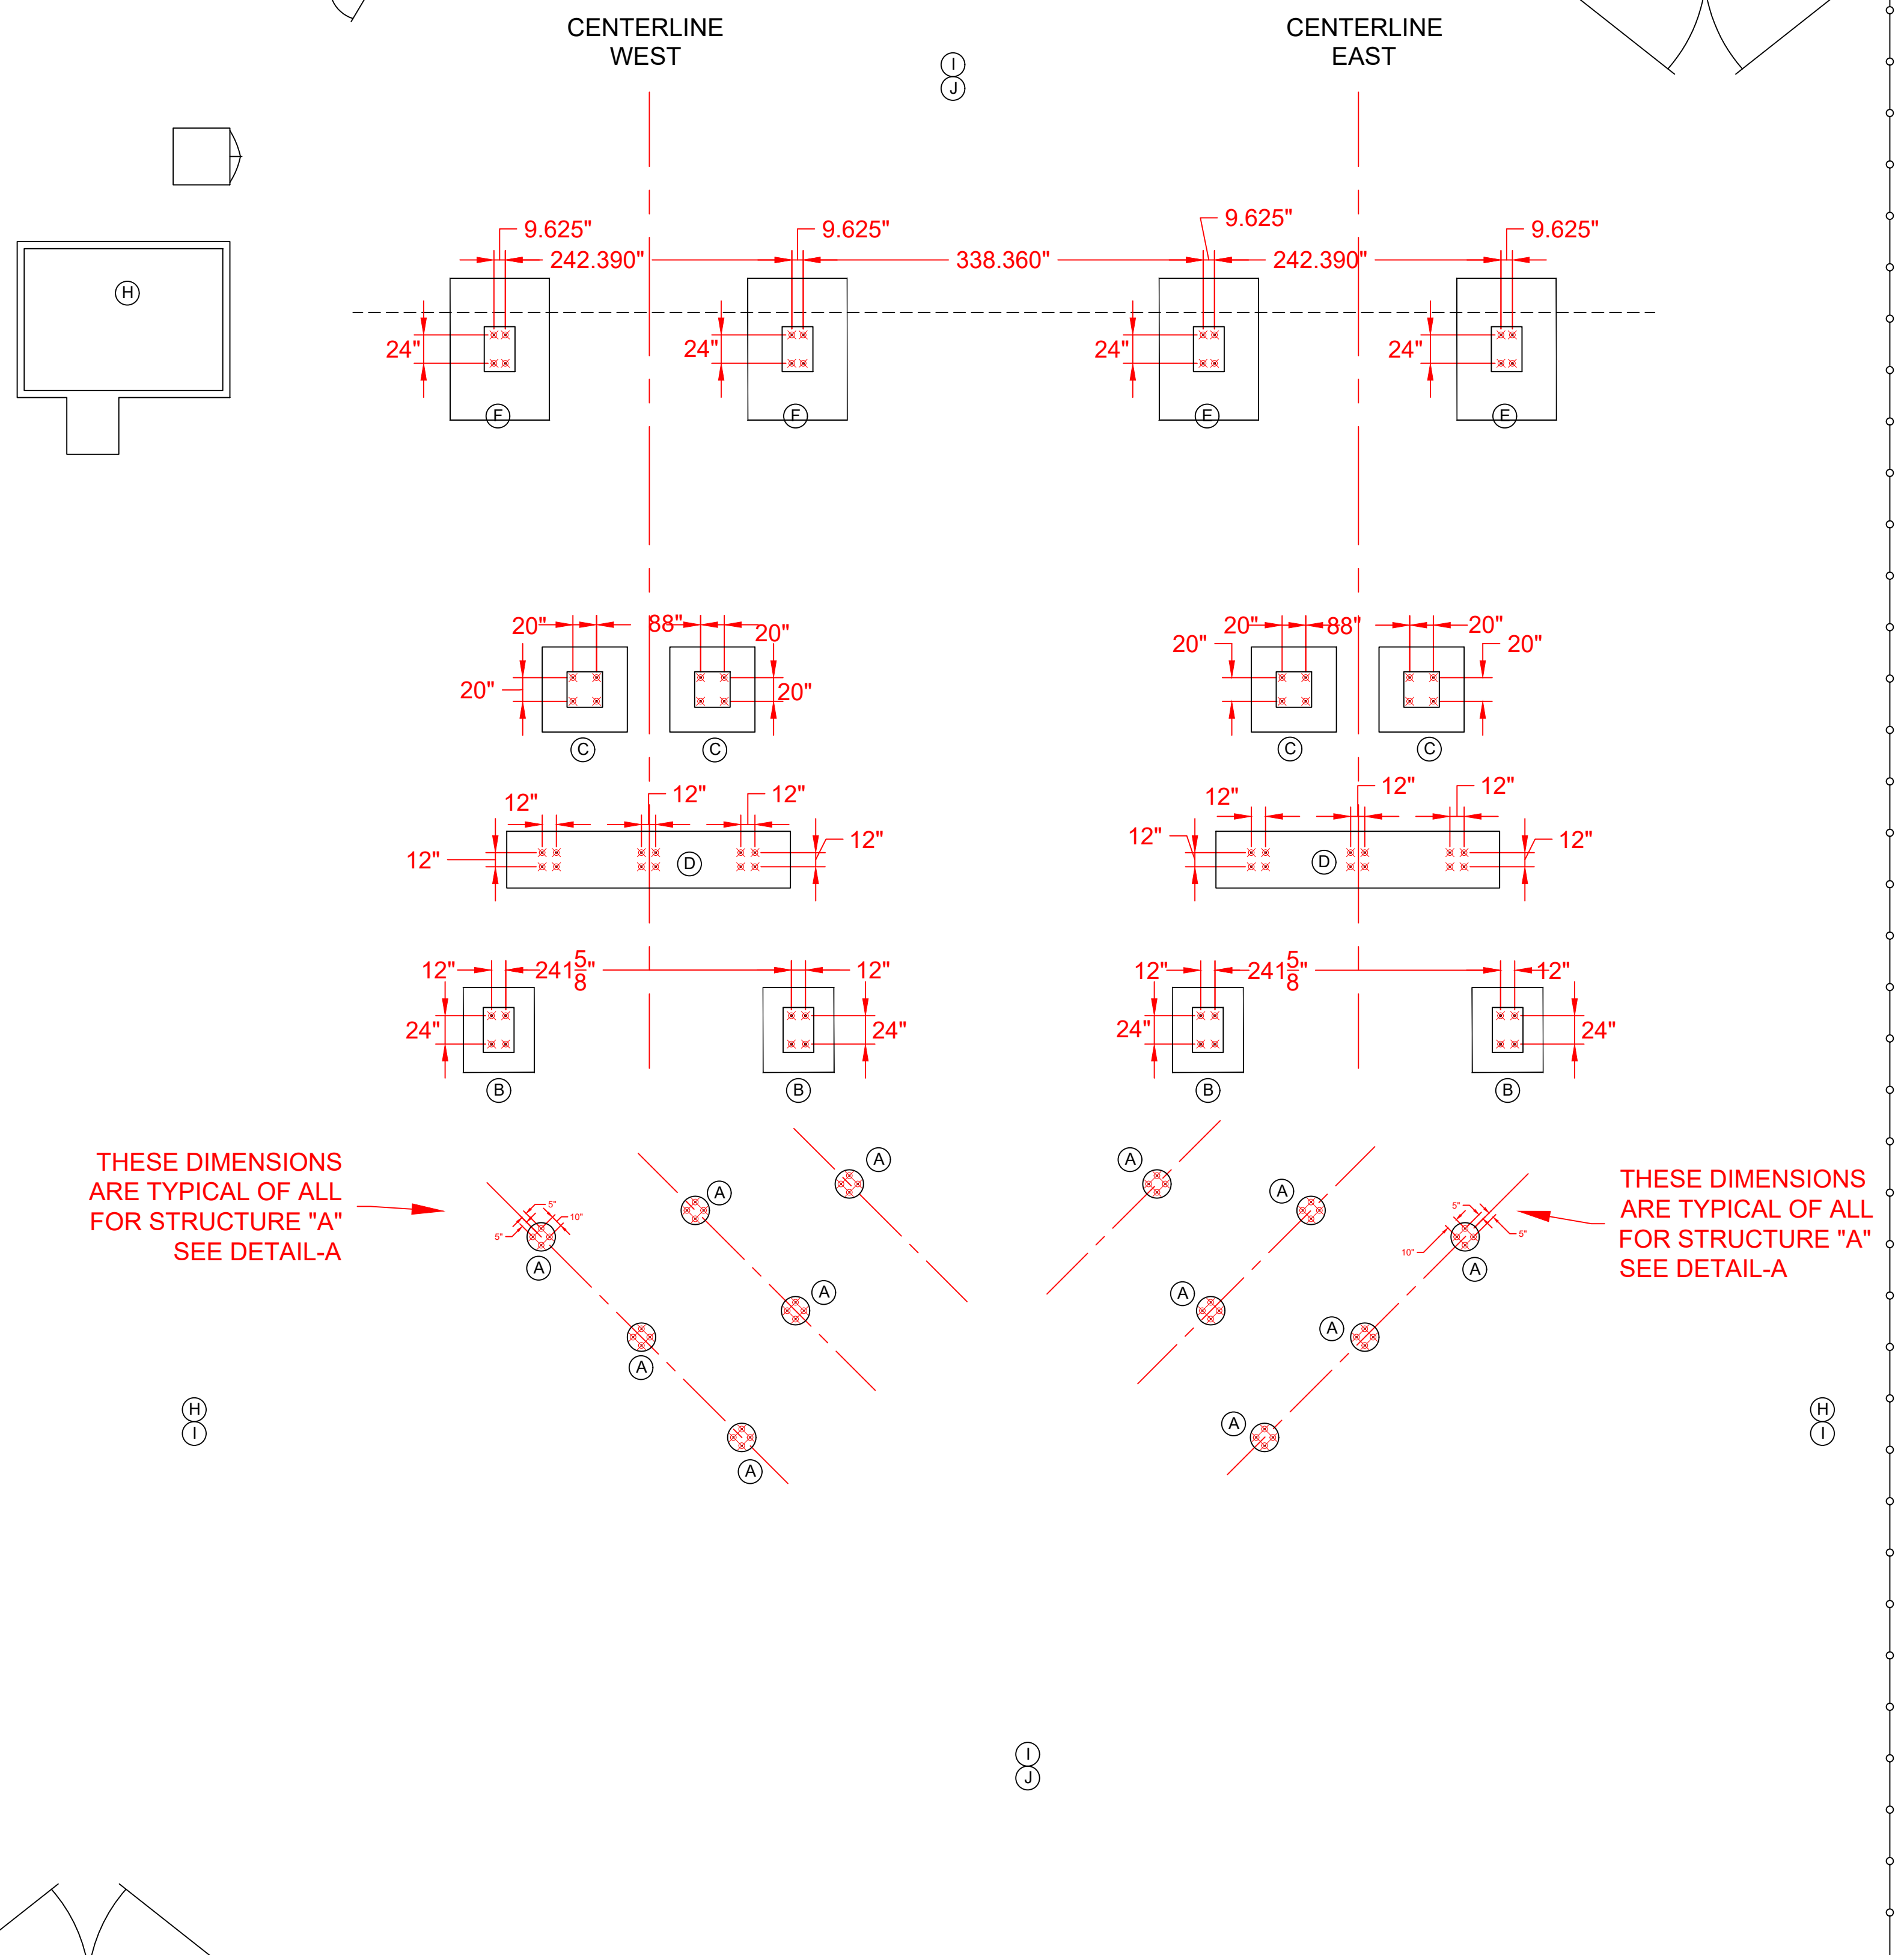

DETAIL-A

REV	REVISIONS	DATE	DRN	DSGN	CKD	APPD	REFERENCE DRAWINGS
1	REVISED TOP OF CONCRETE ELEVATIONS	2/5/24	BENP				
0	ISSUED FOR CONSTRUCTION	12/6/23	BENP				

DSGN	BENP	7/2022
DRN	BENP	7/2022
CKD		
SCALE:	N.T.S.	

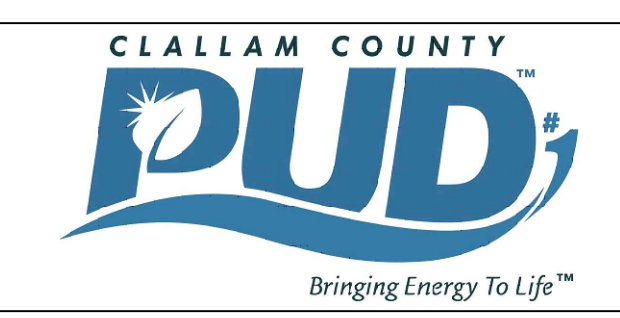

CLALLAM COUNTY PUD
LIBERTY STATION
FOUNDATION PLAN

JOB NUMBER	21-2316	REV	1
DRAWING NUMBER	E4-0-2		

